

MARNHAM ROAD

11

6

● Licensed Area.

Indoor Bowling Club





Existing Stand

Existing Stand


Existing Stand

Swimming Pool



71

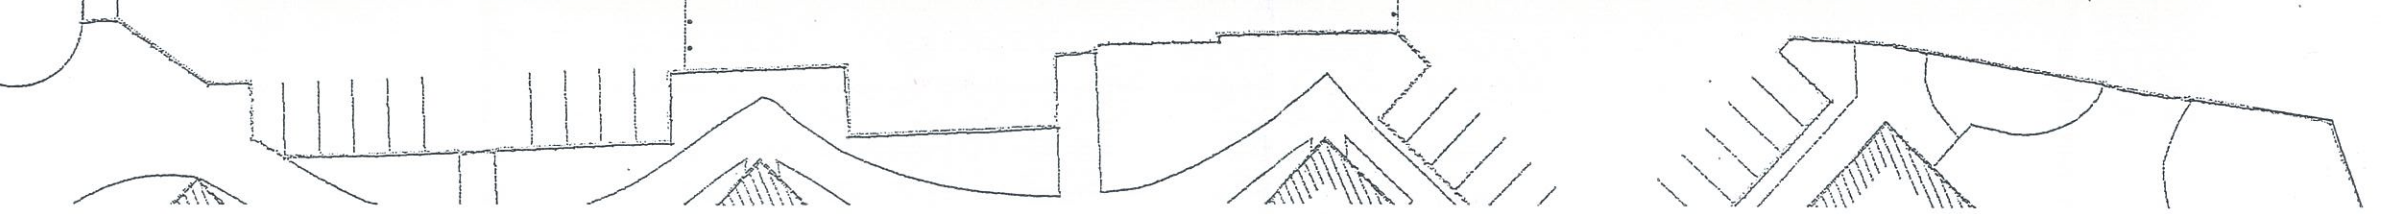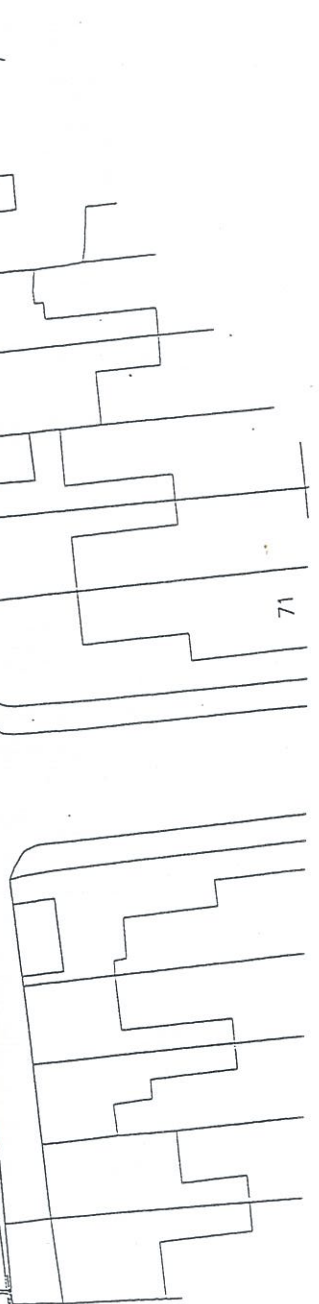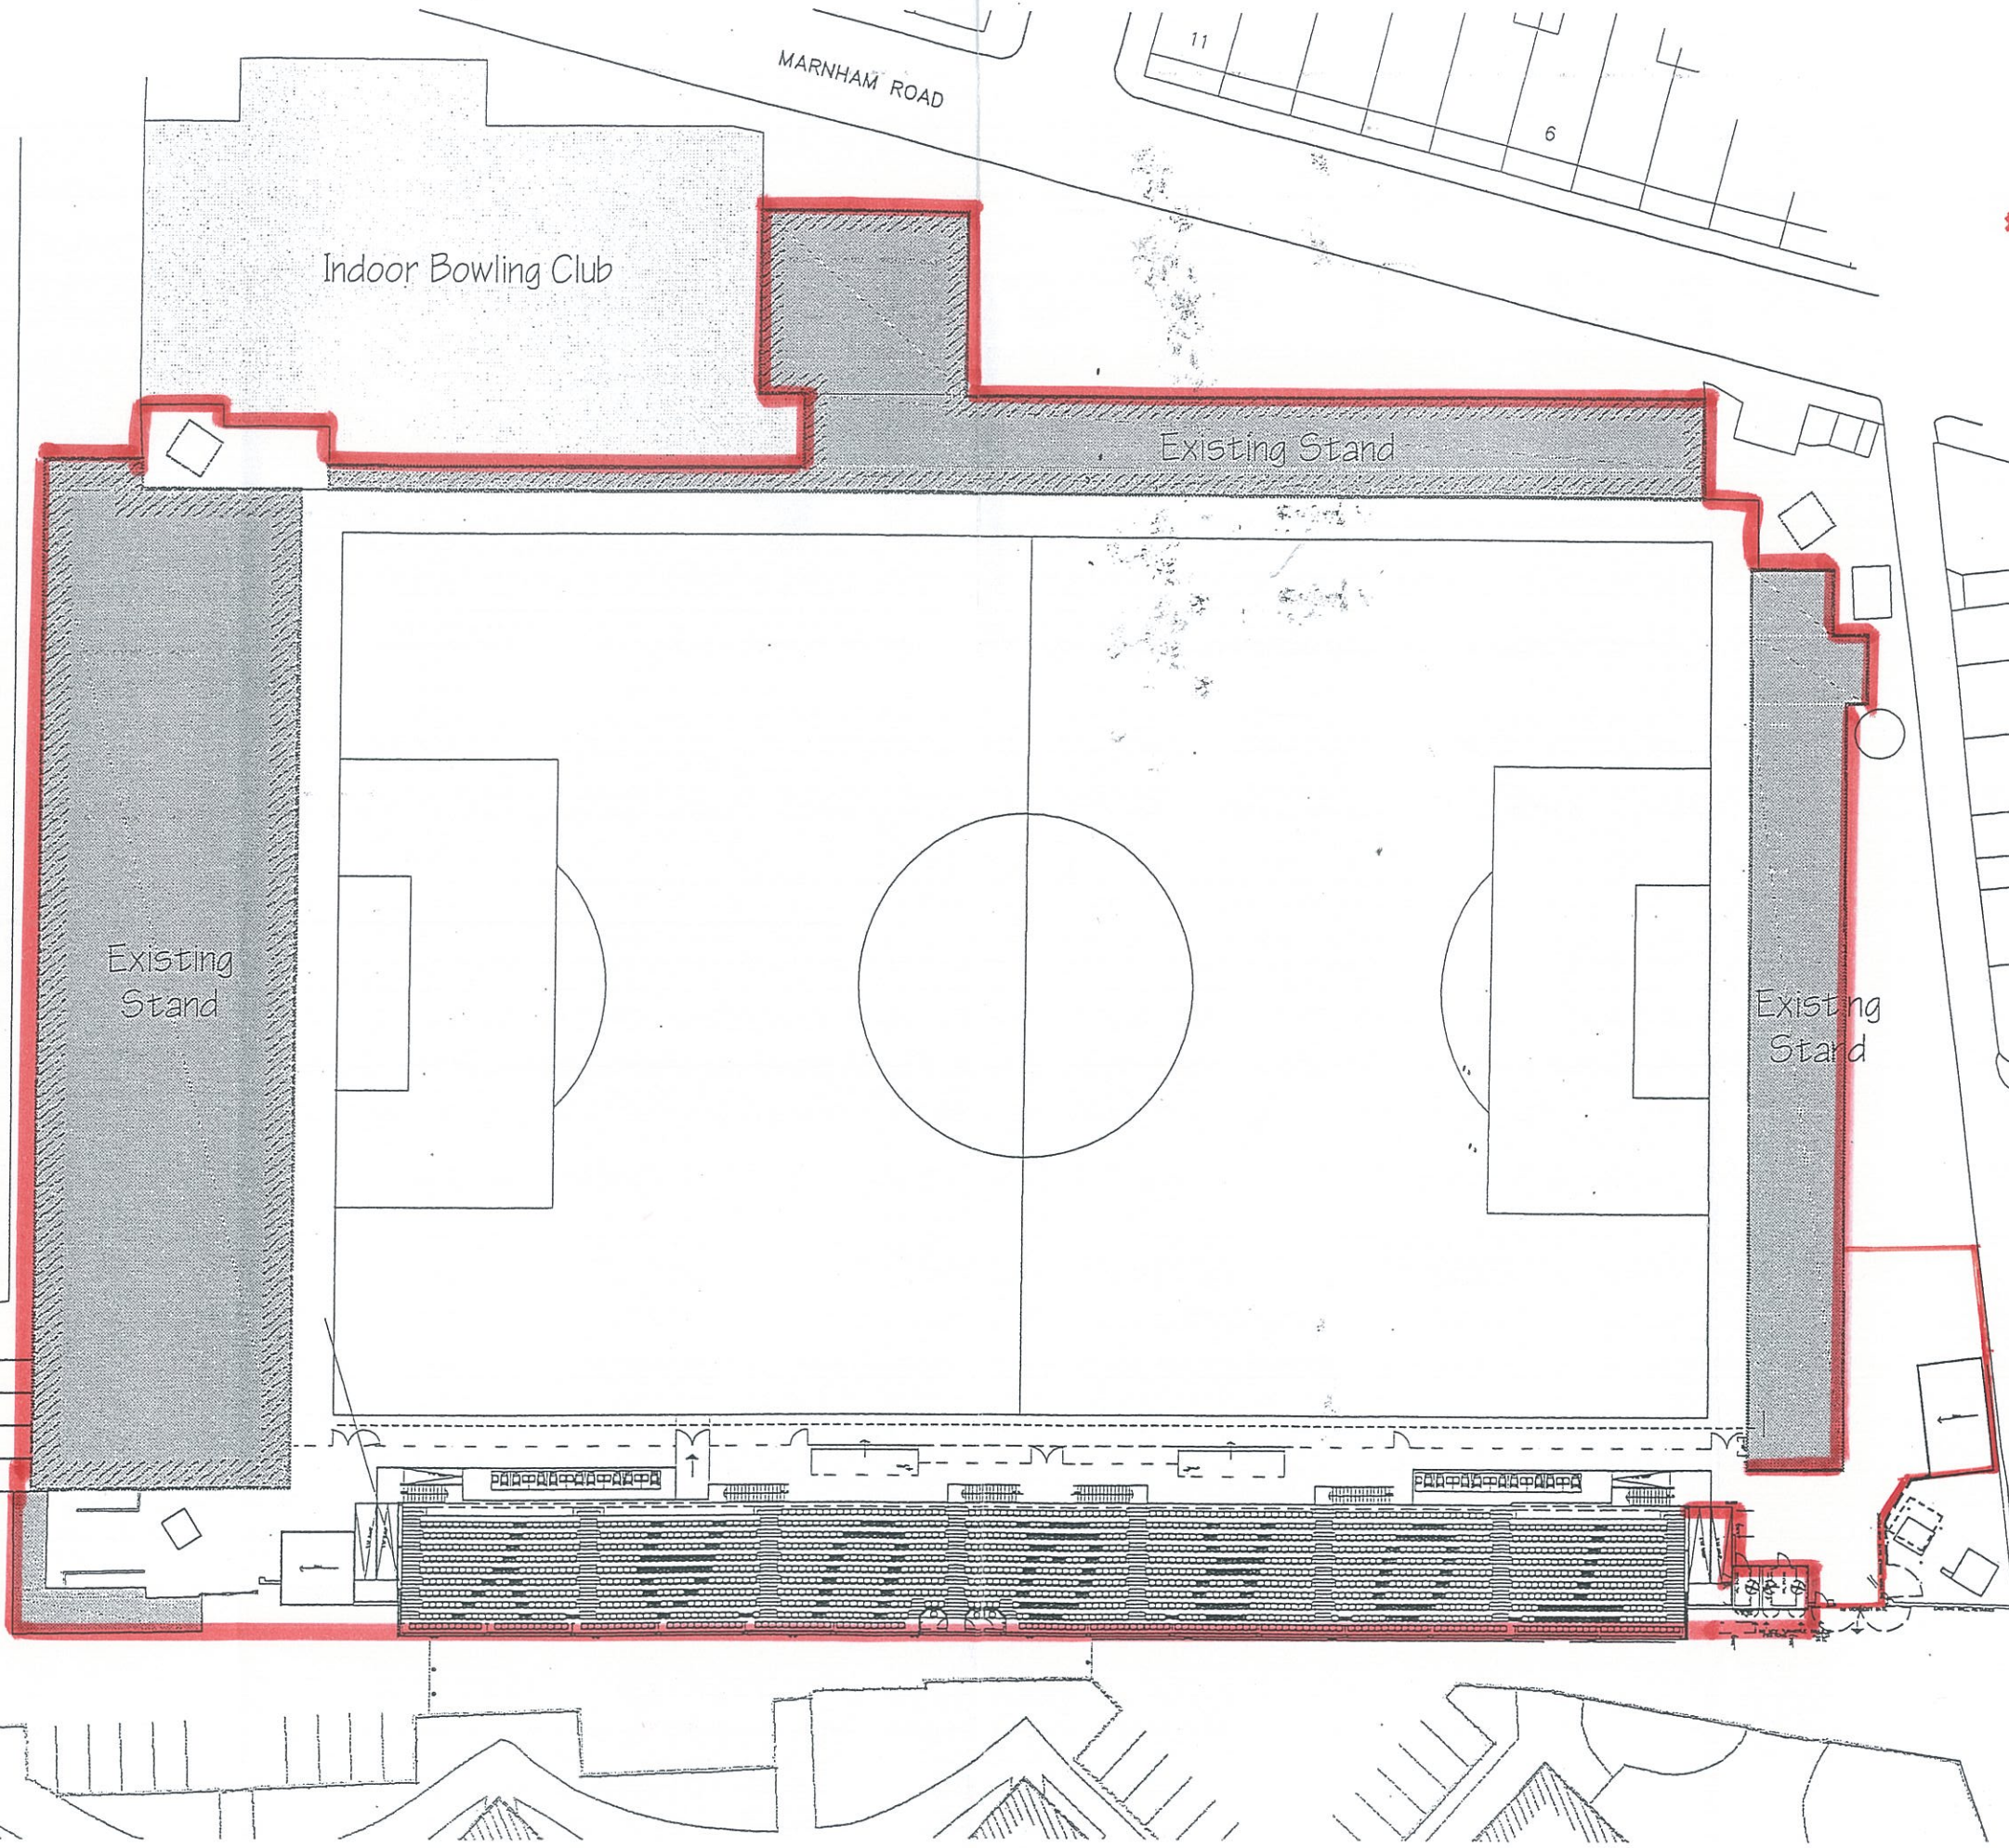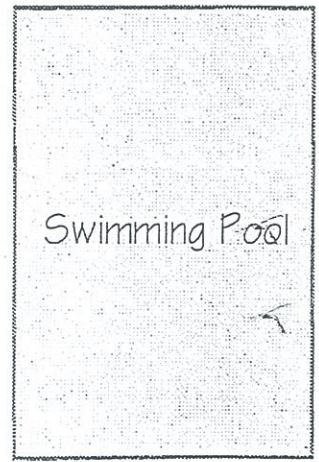

POP SIDE BAR

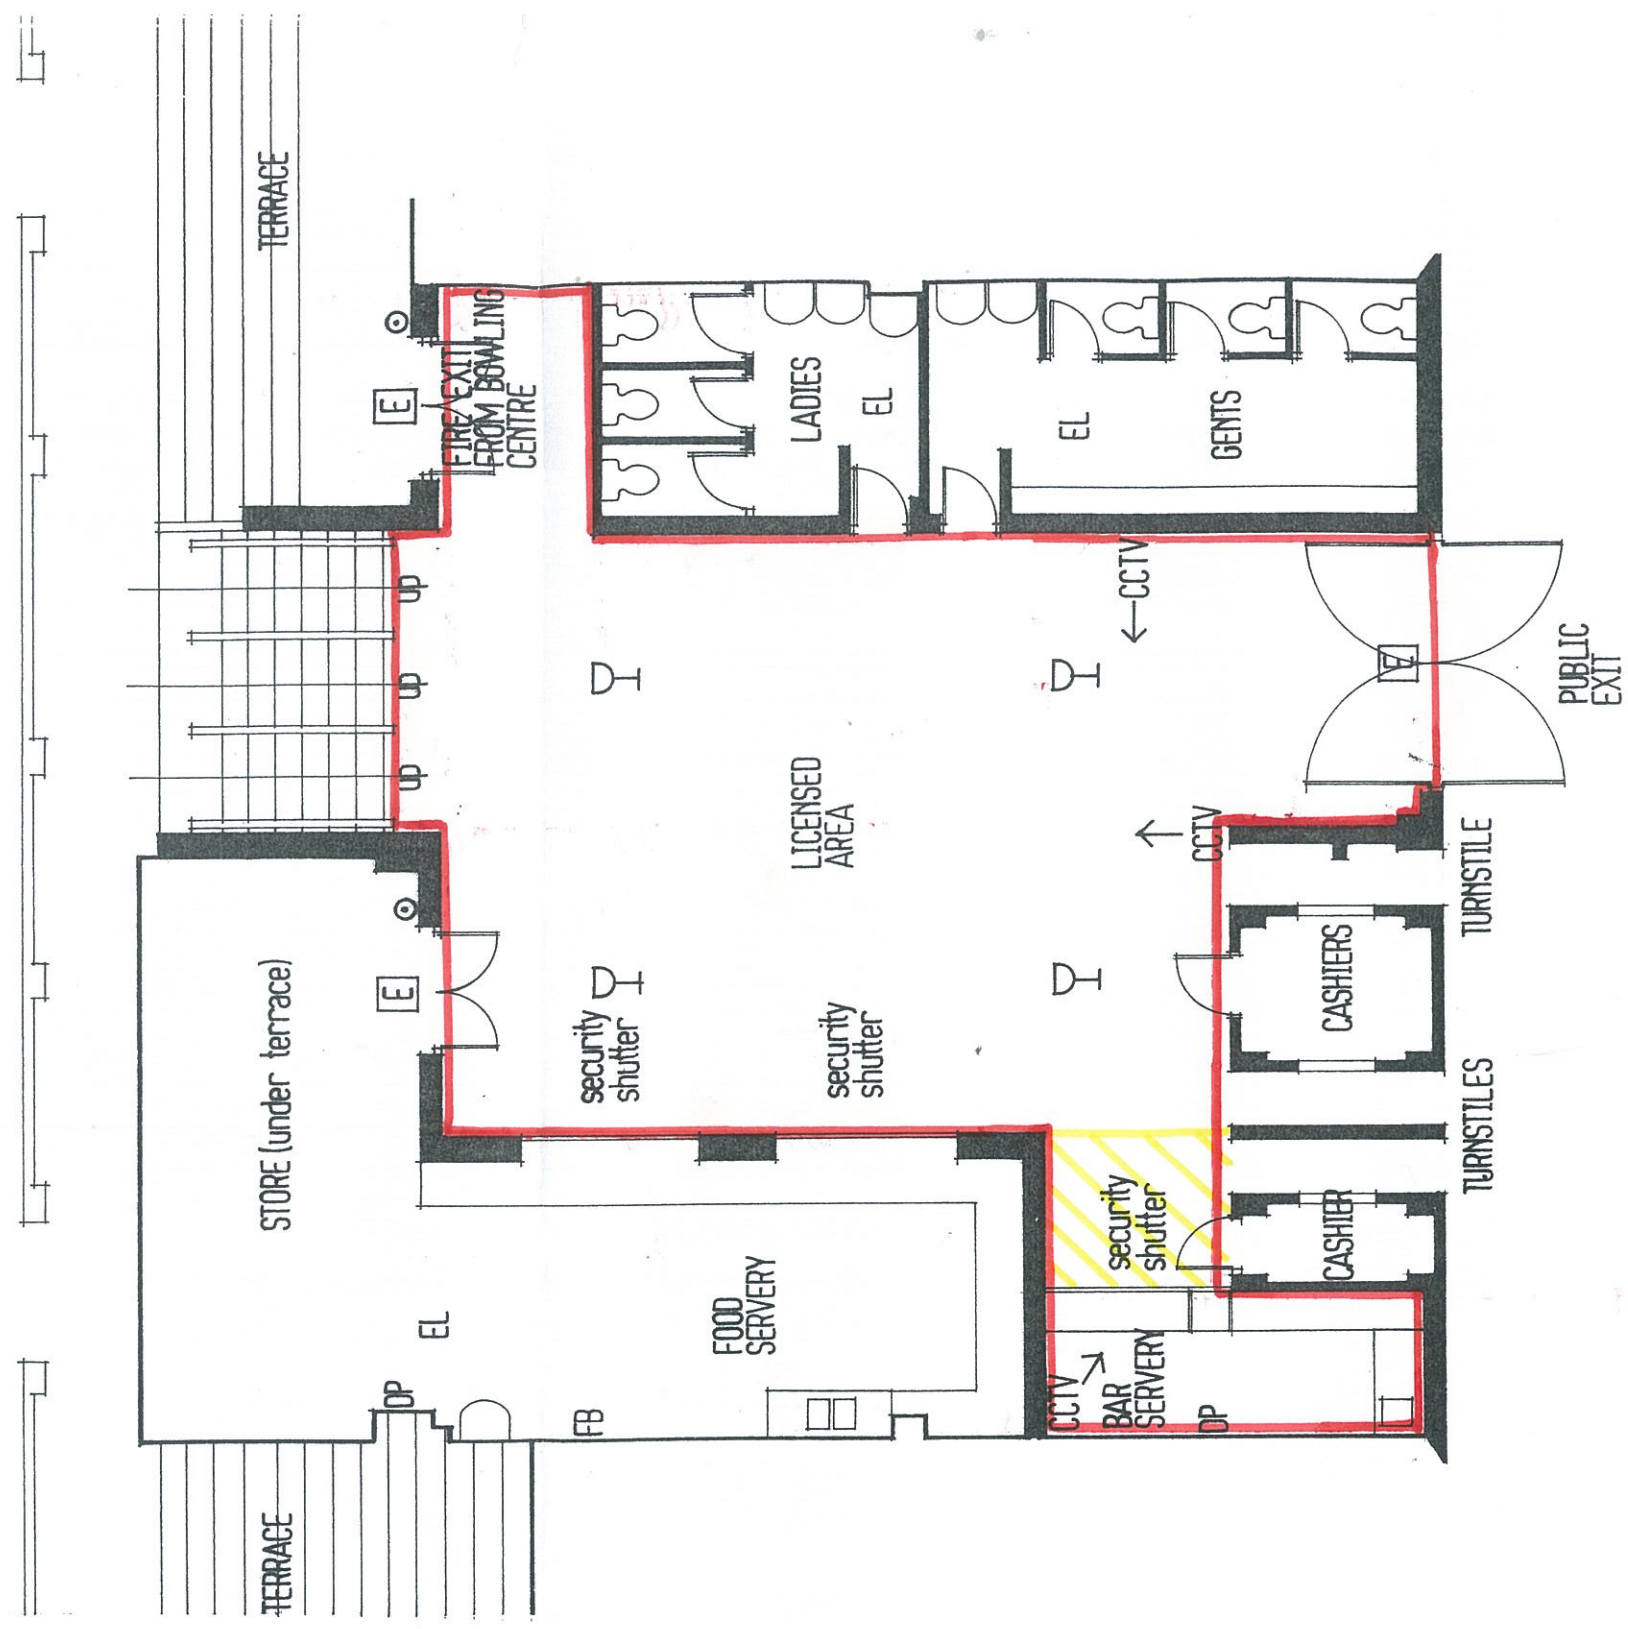



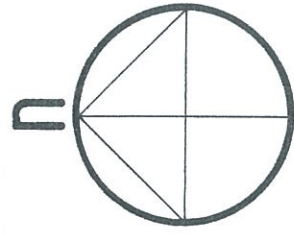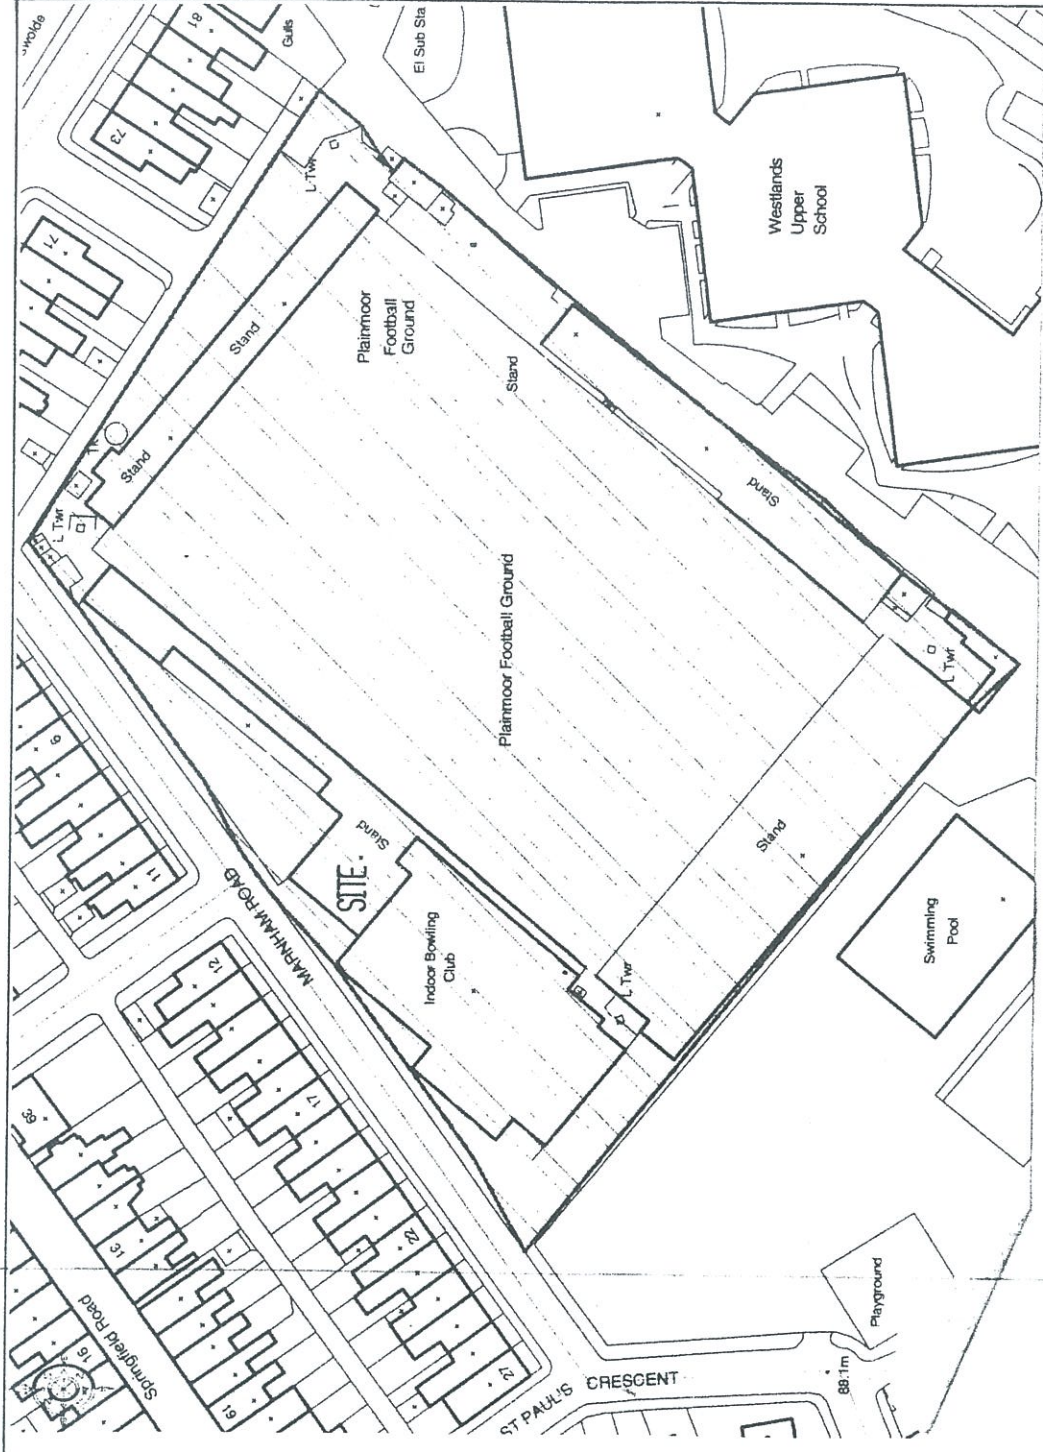




part ground floor plan
(north west stand)



site location plan

LEGEND

-  FIRE EXIT SIGN (illuminated)
-  EMERGENCY LIGHT
-  FIRE ALARM CALLPOINT
-  DRY POWDER EXTINGUISHER
-  FIRE BLANKET
-  CCTV CLOSED CIRCUIT TV CAMERA
-  LICENSED AREA

 LICENSED AREA

 NO UNACCOMPANIED UNDER 16'S

SITE

Pop Side Bar
TORQUAY UNITED AFC
PLAINMOOR
TORQUAY TQ1 3PS

PROJECT
LICENCE APPLICATION

DARREN SIMMER
A R C H I T E C T U R E

9 WESTBOURNE ROAD TORQUAY TQ1 4JT
 Tel/Fax 01803 316399 Email darrensimmer@yahoo.co.uk

SCALES

1:100 1:1250

DATE

8.08

BY

DS


JOB NO.

2071


DRG NO.


05

Gulls Nest
& NO. 10 Restaurant.

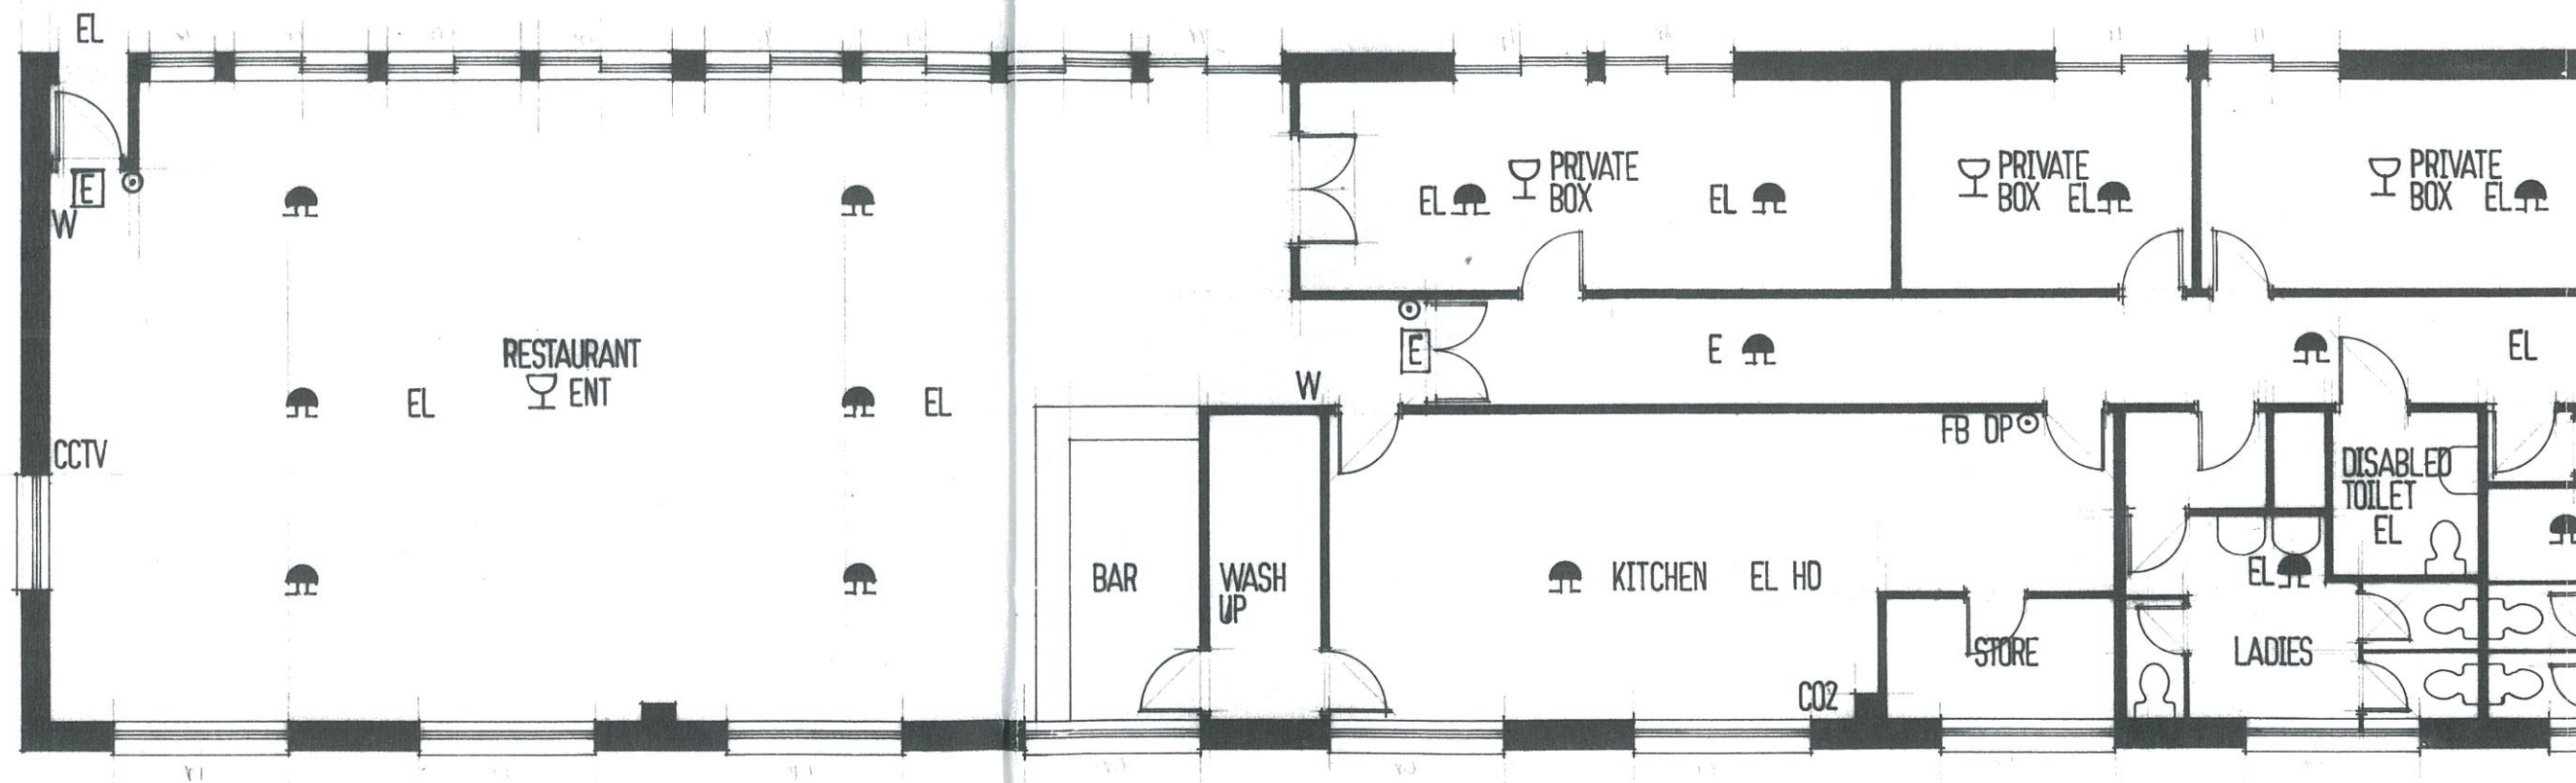


first floor plan

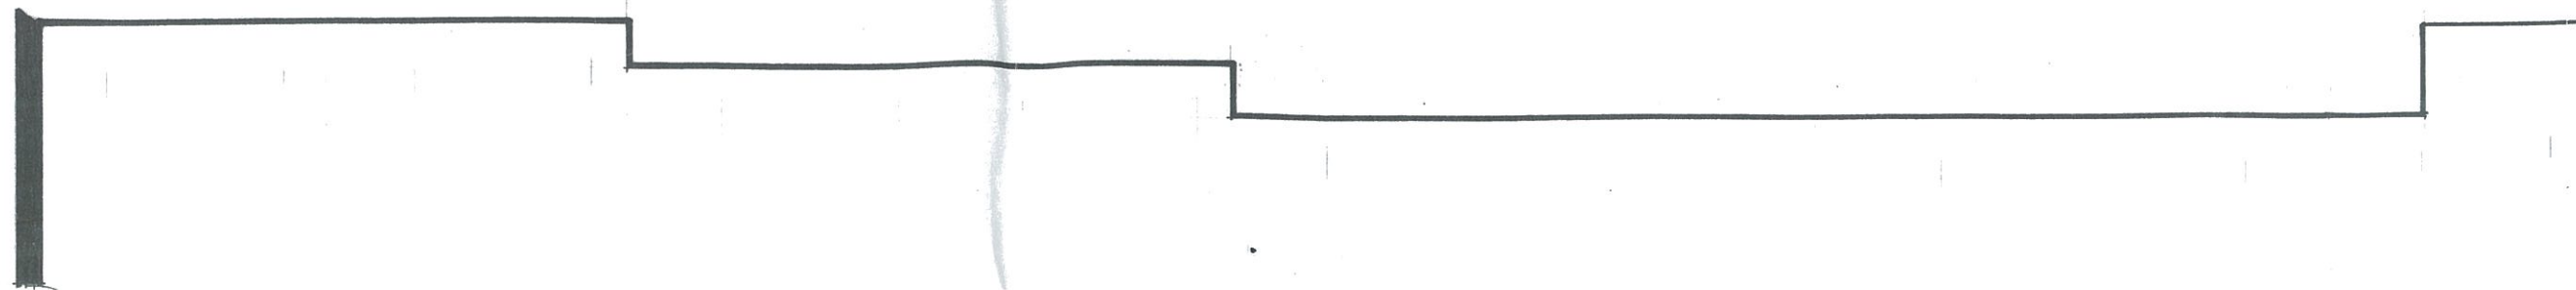

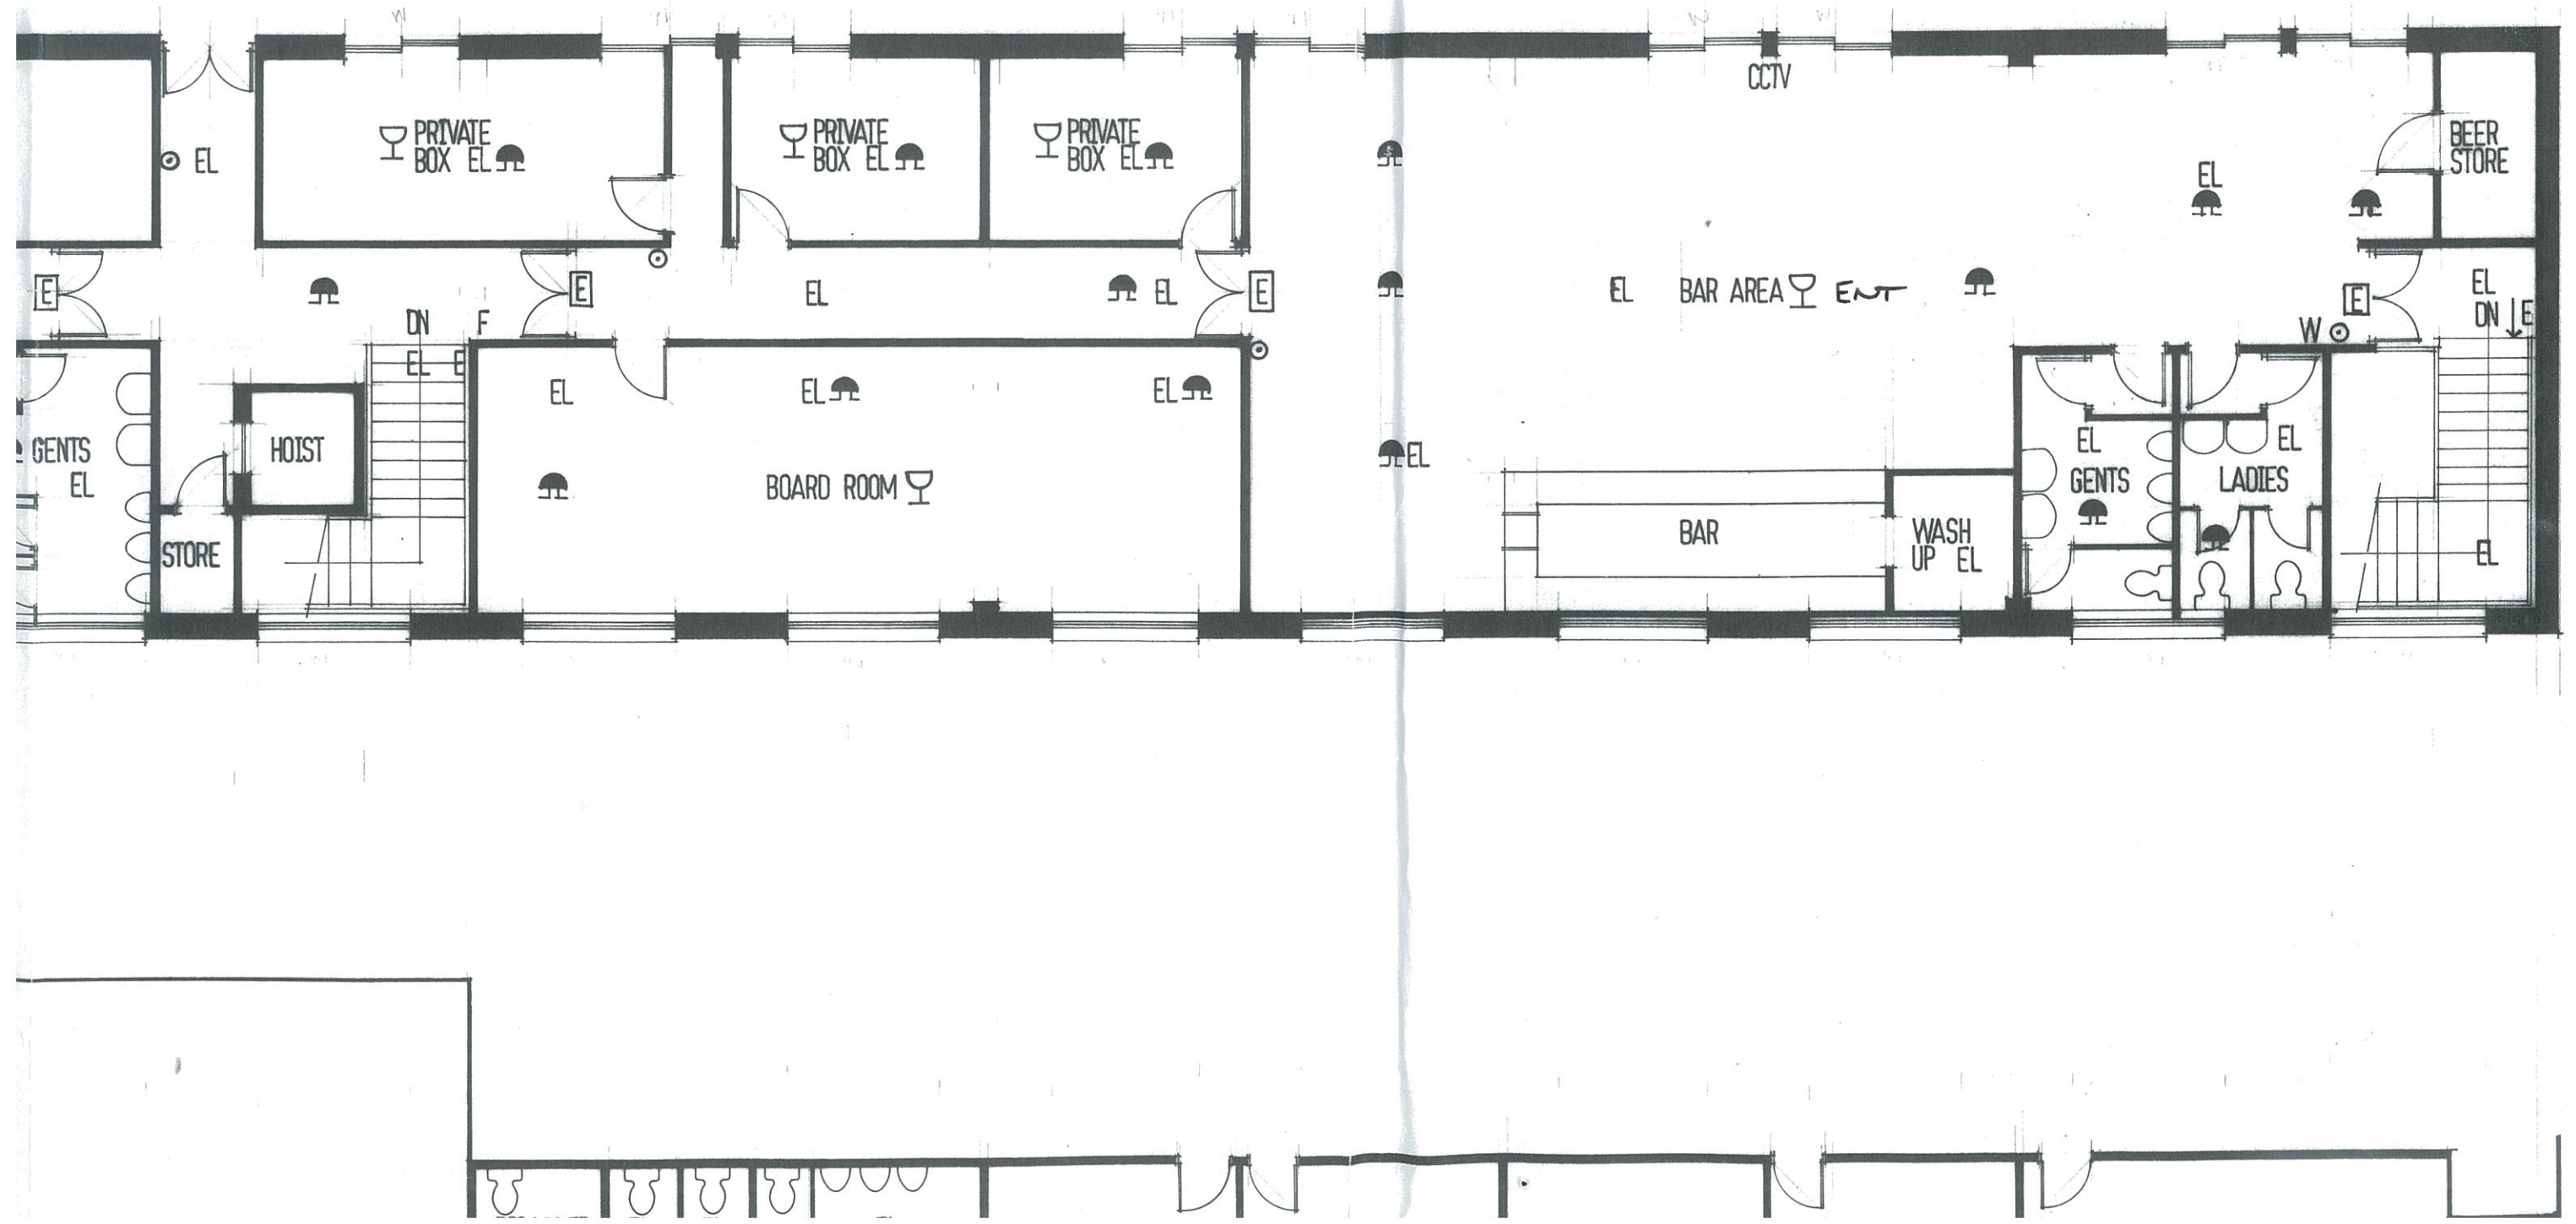



ground floor plan

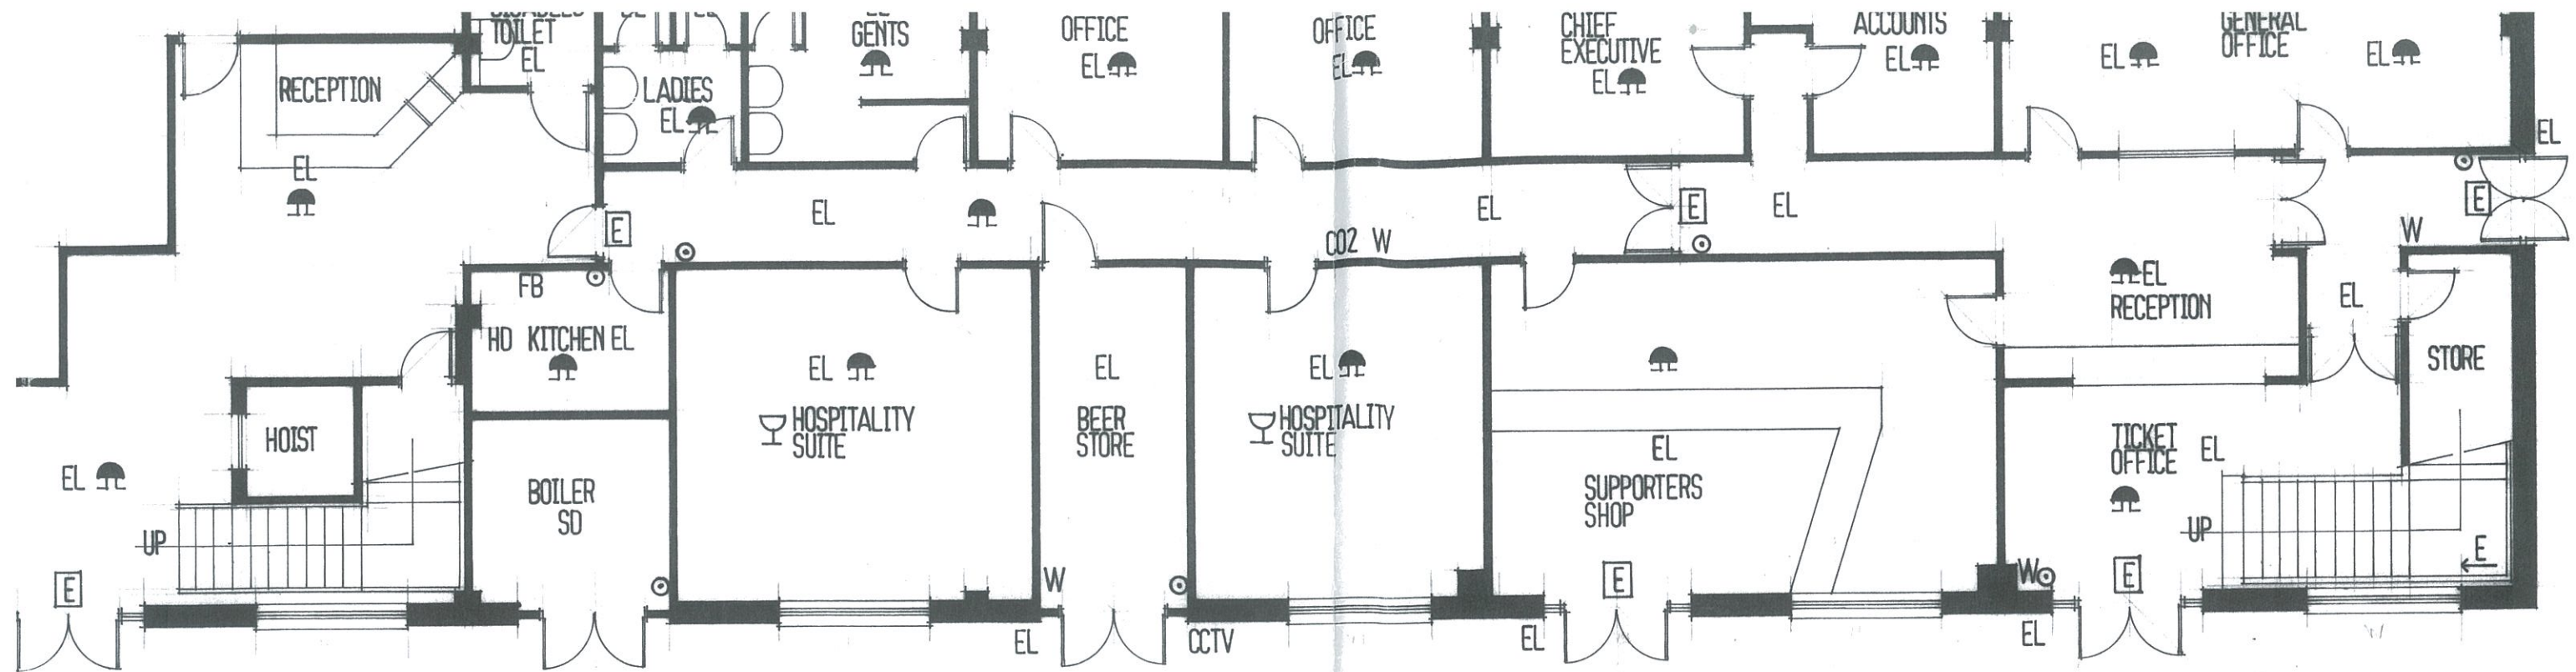

LEGEND

- E FIRE EXIT SIGN (illuminated)
- E FIRE EXIT SIGN (non-illuminated)
- EL EMERGENCY LIGHT
- ⊙ FIRE ALARM CALLPOINT
- ☂ FIRE ALARM SOUNDER
- HD HEAT DETECTOR
- SD SMOKE DETECTOR
- FB FIRE BLANKET
- W WATER FILLED EXTINGUISHER
- CO2 CARBON DIOXIDE EXTINGUISHER
- DP DRY POWDER EXTINGUISHER
- F FOAM FILLED EXTINGUISHER
- CCTV CLOSED CIRCUIT TV CAMERA
- 🍷 LICENSED AREA
- ENT ENTERTAINMENT AREA

site Torquay United PLAINMOOR TORQUAY TQ1 3PS			
project LICENCE APPLICATION			
drawing GROUND & FIRST FLOOR PLAN			
<i>DARREN SIMNER</i> ARCHITECTURE			
9 WESTBOURNE ROAD TORQUAY TQ1 4JT Tel/Fax 01803 316399 Email darrensimner@yahoo.co.uk			
scales 1.100	date 1.08	by DS	job no 2071 drg no 01_B