


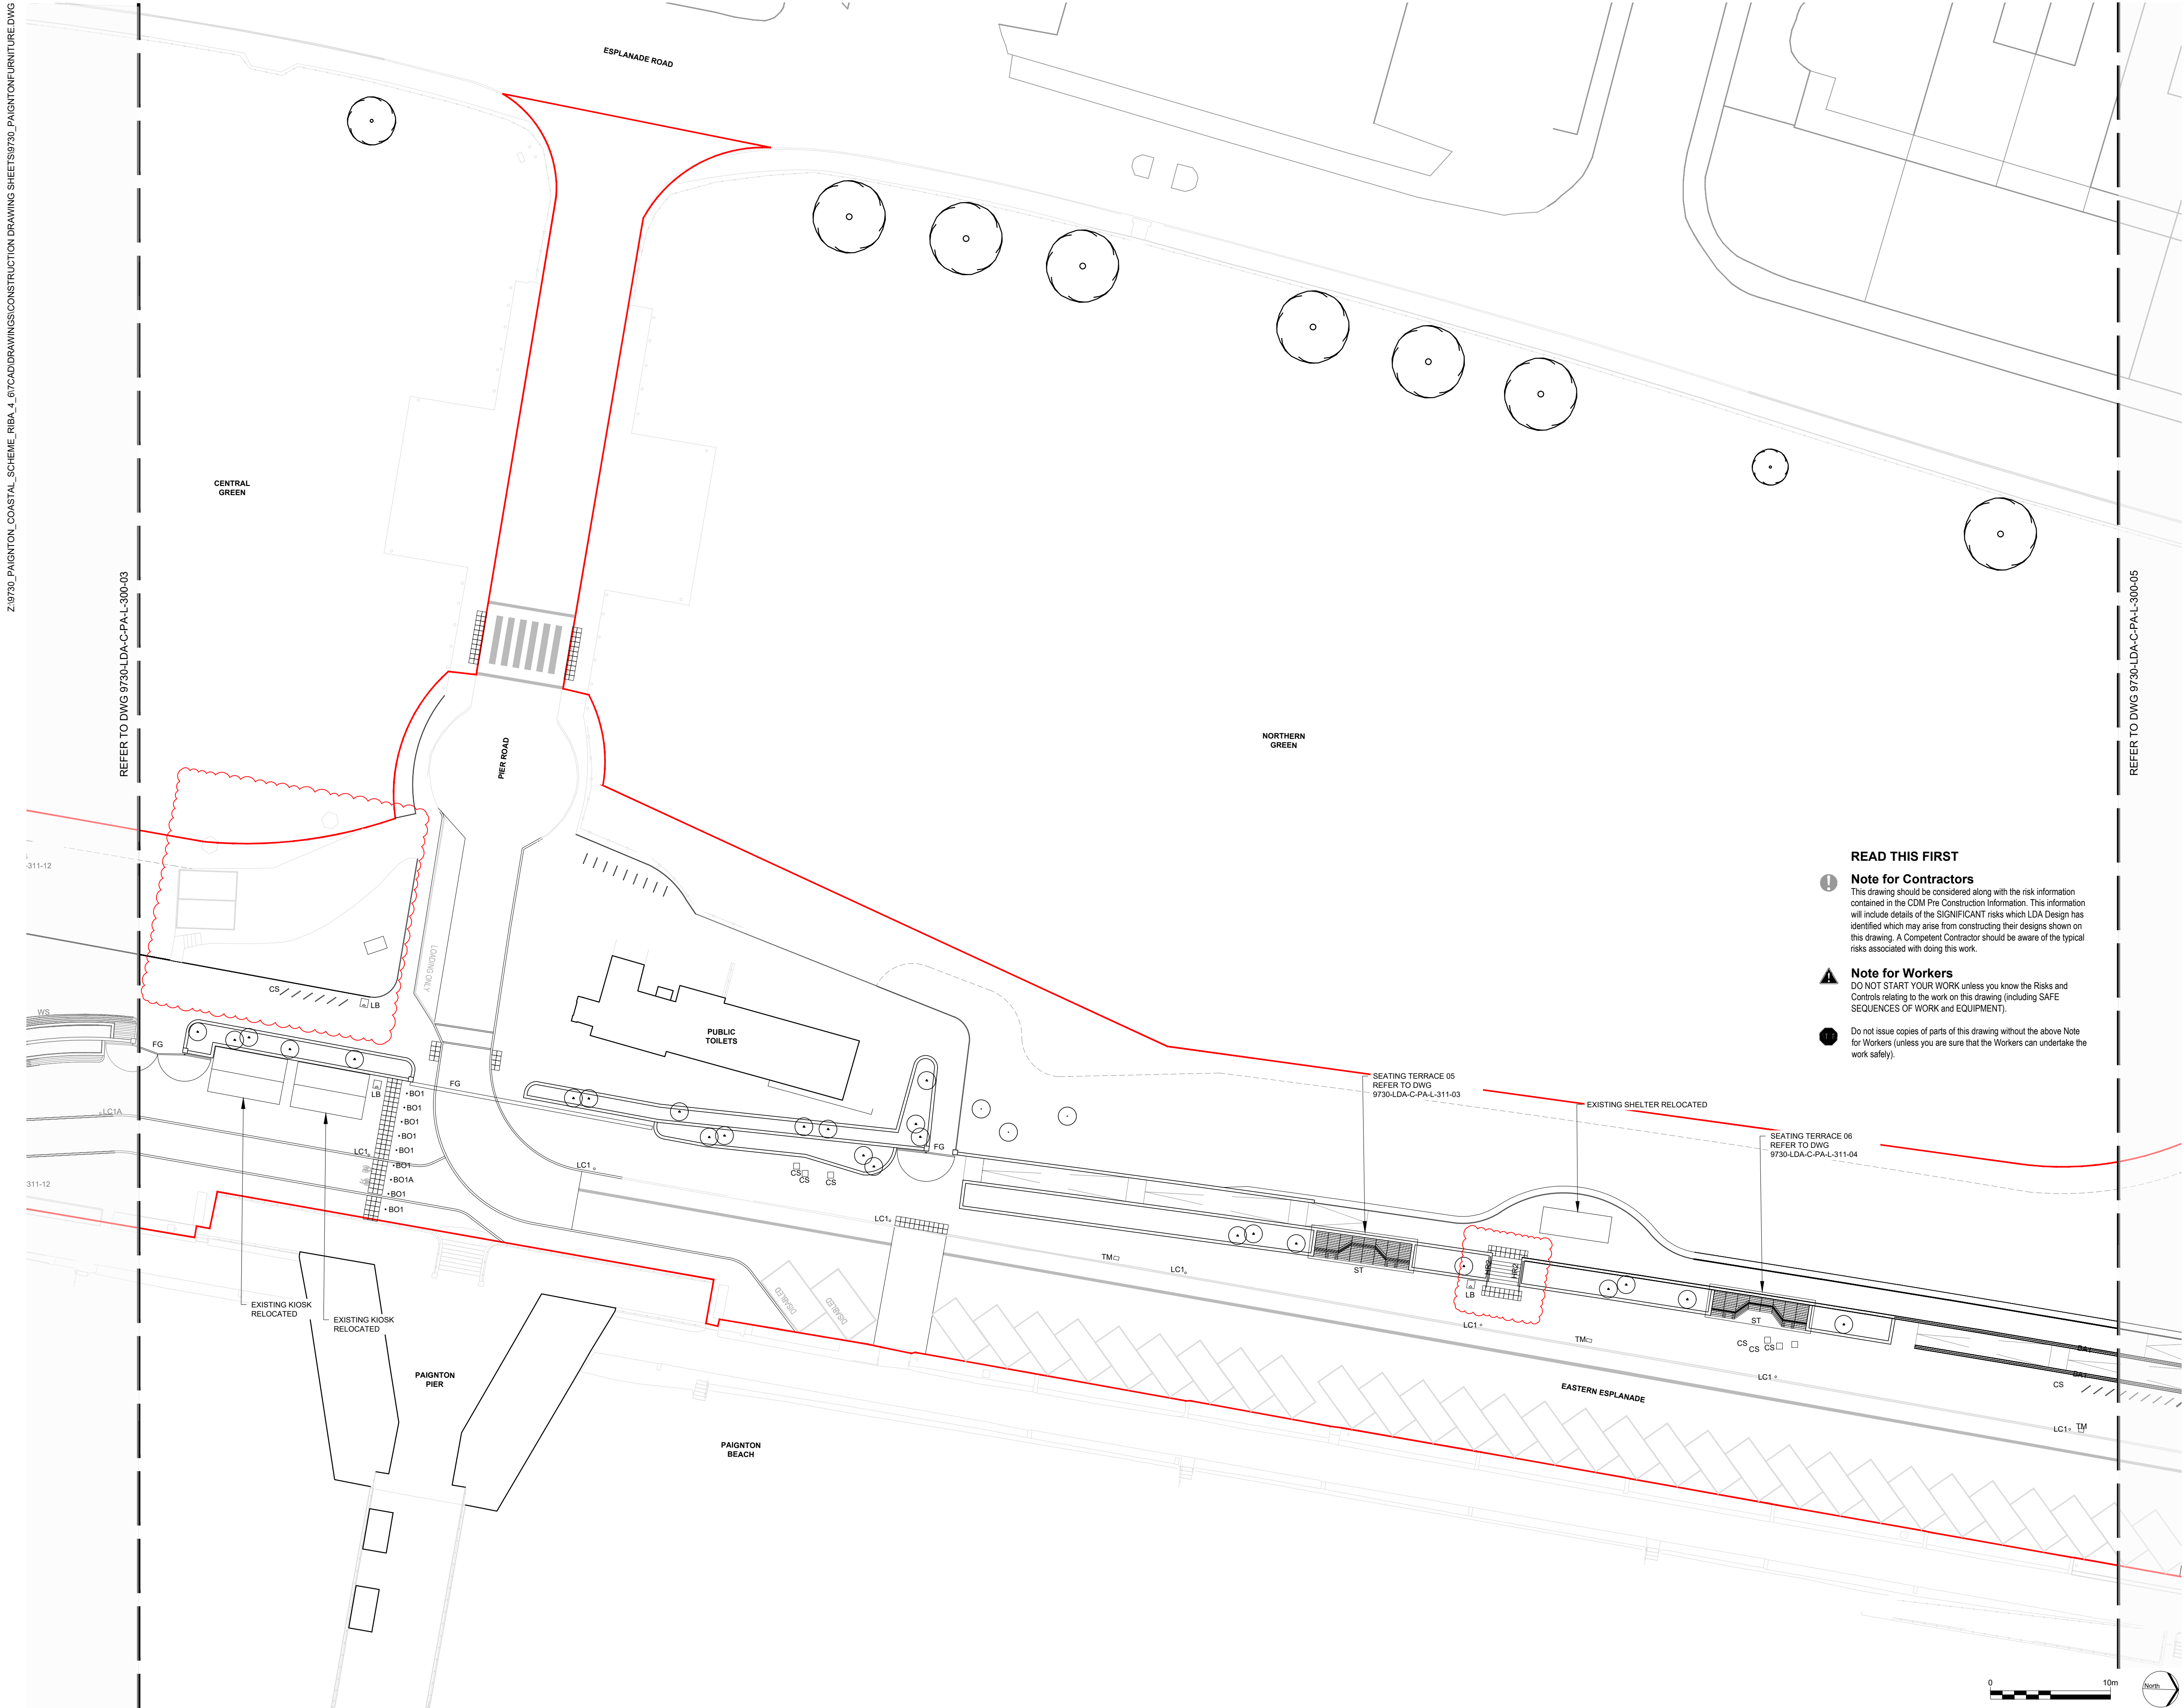

LEGEND

Scheme Boundary

Light Column Type 1
Selux Olvio Sistema

Light Column Type 1A
Selux Olvio Sistema with Gobo projector

Light Column Type 3
Highways Column
Refer to Engineer's information

Illuminated Bollard
Selux Inula

Sheffield Cycle Stand
316 Stainless Steel

Bollard Type 1
316 Stainless Steel

Bollard Type 1A (Folding)
316 Stainless Steel

Big Belly Litter Bin (89L)

Balustrade

Handrail Type 1 (Step Mounted)

Handrail Type 1A (Step Mounted)

Handrail Type 2 (Wall Mounted)

Handrail Type 2A (Wall Mounted With Landing)

Handrail Type 2B (Wall Mounted With Landing)

Timber Cube Seat

Timber Seating Terrace

Timber Wall Seat

Timber Picnic Bench

Flood Gate
Refer to Engineer's Information

Climbing Wall
Refer to Landscape Specification

Climbing Ropes
Refer to Landscape Specification

Climbing Holds
Refer to Landscape Specification

Stepping Stones
Refer to Landscape Specification

Slide
Refer to Landscape Specification

Ticket Machine

CCTV columns

READ THIS FIRST

⚠

Note for Contractors

This drawing should be considered along with the risk information contained in the CDM Pre Construction Information. This information will include details of the SIGNIFICANT risks which LDA Design has identified which may arise from constructing their designs shown on this drawing. A Compliant Contractor should be aware of the typical risks associated with doing this work.

⚠

Note for Workers

DO NOT START YOUR WORK unless you know the Risks and Controls relating to the work on this drawing (including SAFE SEQUENCES OF WORK AND EQUIPMENT).

⚠

Do not issue copies of parts of this drawing without the above Note for Workers (unless you are sure that the Workers can undertake the work safely).

- For Paignton Furniture and Lighting Layout and Reference Plans refer to DWGs 9730-LDA-C-PAL-300-01 to 9730-LDA-C-PAL-300-05

- For Preston Furniture and Lighting Layout and Reference Plans refer to DWGs 9730-LDA-C-PR-L-300-01 to 9730-LDA-C-PR-L-300-03

- For Paignton Balustrade and Handrail Details refer to DWGs 9730-LDA-C-PAL-310-01 to 9730-LDA-C-PAL-310-03 and 9730-LDA-C-PAL-310-05

- For Preston Balustrade and Handrail Details refer to DWGs 9730-LDA-C-PR-L-310-11 and 9730-LDA-C-PR-L-310-12

- For Paignton Seating Terrace Details refer to DWGs 9730-LDA-C-PR-L-310-15 to 9730-LDA-C-PR-L-310-16

- For Paignton Seating Terrace Details refer to DWGs 9730-LDA-C-PAL-311-01 to 9730-LDA-C-PAL-311-04

- For Paignton Wall Seat Details refer to DWGs 9730-LDA-C-PAL-311-05 to 9730-LDA-C-PAL-311-05 to 12

- For Paignton Arm Rest Detail refer to DWG 9730-LDA-C-PAL-311-20

- For Preston Wall Seat Details refer to DWGs 9730-LDA-C-PR-L-311-30 to 9730-LDA-C-PR-L-311-30

- For Timber Seating Cube Details refer to DWG 9730-LDA-C-PAL-311-50

- For Preston Timber Bench and Preston Timber Platform Bench refer to 9730-LDA-C-PR-L-311-51

- Drawings to be read in conjunction with External Works Specification 9730-LDA-C-XX-L-900-01

NOTES:

1. THIS DRAWING IS TO BE READ IN CONJUNCTION WITH ALL OTHER DRAWINGS AND SPECIFICATIONS.

2. DO NOT SCALE OFF THIS DRAWING. WRITTEN DIMENSIONS TO BE TAKEN ONLY.

3. ANY DISCREPANCIES FOUND BETWEEN THIS DRAWING AND OTHER DRAWINGS AND SPECIFICATIONS IN THE CONSTRUCTION DOCUMENTS MUST BE REFERRED TO THE LANDSCAPE ARCHITECT PRIOR TO WORK COMMENCING.

4. THIS DRAWING MUST NOT BE COPIED IN WHOLE OR IN PART WITHOUT WRITTEN CONSENT OF LDA DESIGN.

5. THESE DRAWINGS ARE FOR FINISHES ONLY. ALL FOUNDATION, FIXING, PAVING DEPTHS AND DRAINAGE DETAILS TO BE PROVIDED BY OTHERS.

6. ALL DIMENSIONS ARE IN MM UNLESS OTHERWISE STATED.

7. WHERE DIMENSION SIZES OF UNITS ARE GIVEN THEY STATE LENGTH X WIDTH X DEPTH.

T02 Issue for Tender

T01 Issue for Tender

REV.

DESCRIPTION

APP.

DATE

LDAD

DESIGN

TORBAY COUNCIL

PROJECT TITLE

Paignton and Preston Coastal Scheme

DRAWING TITLE

Paignton Furniture Layout and reference Sheet 04 of 05

ISSUED BY

Exeter

T: 01392 260 430

DATE

Nov 2024

DRAWN

FG

SCALE

1:250

CHECKED

KB

STATUS

Tender

APPROVED

RA

DWG. NO

9730-LDA-C-PAL-300-04

No dimensions are to be scaled from this drawing. All dimensions are to be checked on site. Area measurements for indicative purposes only.

Sources

Ordnance Survey

0

10m

North

This drawing may contain: Ordnance Survey material by permission of Ordnance Survey on behalf of the Controller of Her Majesty's Stationery Office © Crown Copyright 2022. All rights reserved. Reference number 0100031673.
OS Open data / © Natural England / © DEFRA / © DECC / © Historic England / © Environment Agency, Aerial Photography - ESRI, DigitalGlobe, GEOEye, i-cubed, USDA FSA, USGD, AEX, Getmapping, Aerogrid, IGN, IGP, swisstopo, the GIS User Community